



Bids and Awards Committee

Project Title: Security Manpower Services for SEC Main Office and Extension Offices

Bid Bulletin No.1

All Prospective Bidders are hereby informed of the following amendments to the SEC Bidding Documents:

PARTICULARS	AMENDMENT/CLARIFICATION
Page 61, Additional Requirement (B.1 SEC HEAD Office) Item No.3 33 units of CCTV Cameras, High Resolution	See attached Proposed Installation of CCTV-Cameras with Office Layout.
Page 65, Section VII. Technical Specification under Item No. II Years of Experience	Prospective bidders must submit a certification issued by the Supervisory Office for Security and Investigation Agency of PNP or issued by the President of the Security Agency under oath supported by contracts.
Page 65, Section VII. Technical Specification under Item No. III Security Plan	Prospective bidders to submit their respective detailed Security Plan.

This Bid Bulletin No. 2 shall form an integral part of the Bidding Documents.


August 4, 2017

EMMANUEL Y. ARTIZA
Chairman

Proposed Installation of CCTV-Cameras

OFFICE	QTY CCTV System	QTY CCTV Camera	QTY CCTV Monitor	Location	Estimated Distance (CCTV System- Camera Heads)
SEC HEAD OFFICE					
PICC	1 SET	15	2	Monitor - Chairman's Office & GSD; Cameras - see attached lay-out	see attached lay-out
EDSA	1 SET	3	1	Monitor - Guard's Office Cameras - Front door, back door & Yard area	30M
SEC EXTENSION OFFICE					
BAGUIO	1 SET	2	1	Monitor - director's office; Camera- main entrance & hallway	15M
TARLAC	1 SET	2	1	Monitor - director's office; Camera- main entrance & office area	10M
LEGAZPI	1 SET	2	1	Monitor - director's office; Camera- main entrance & office area	15M
CEBU	1 SET	4	1	Monitor - director's office; Camera- main entrance & office areas (ground and second floor)	30M
ILOILO	1 SET	4	1	Monitor - director's office; Camera- main entrance & office areas (ground and second floor)	30M
CAGAYAN	1 SET	2	1	Monitor - director's office; Camera- main entrance & office area	15M
ZAMBOAN	1 SET	2	1	Monitor - director's office; Camera- main entrance & office area	15M
DAVAO	1 SET	3	1	Monitor - director's office; Camera- main entrance & office area	30M

PROPOSED LOCATION OF CCTV CAMERAS


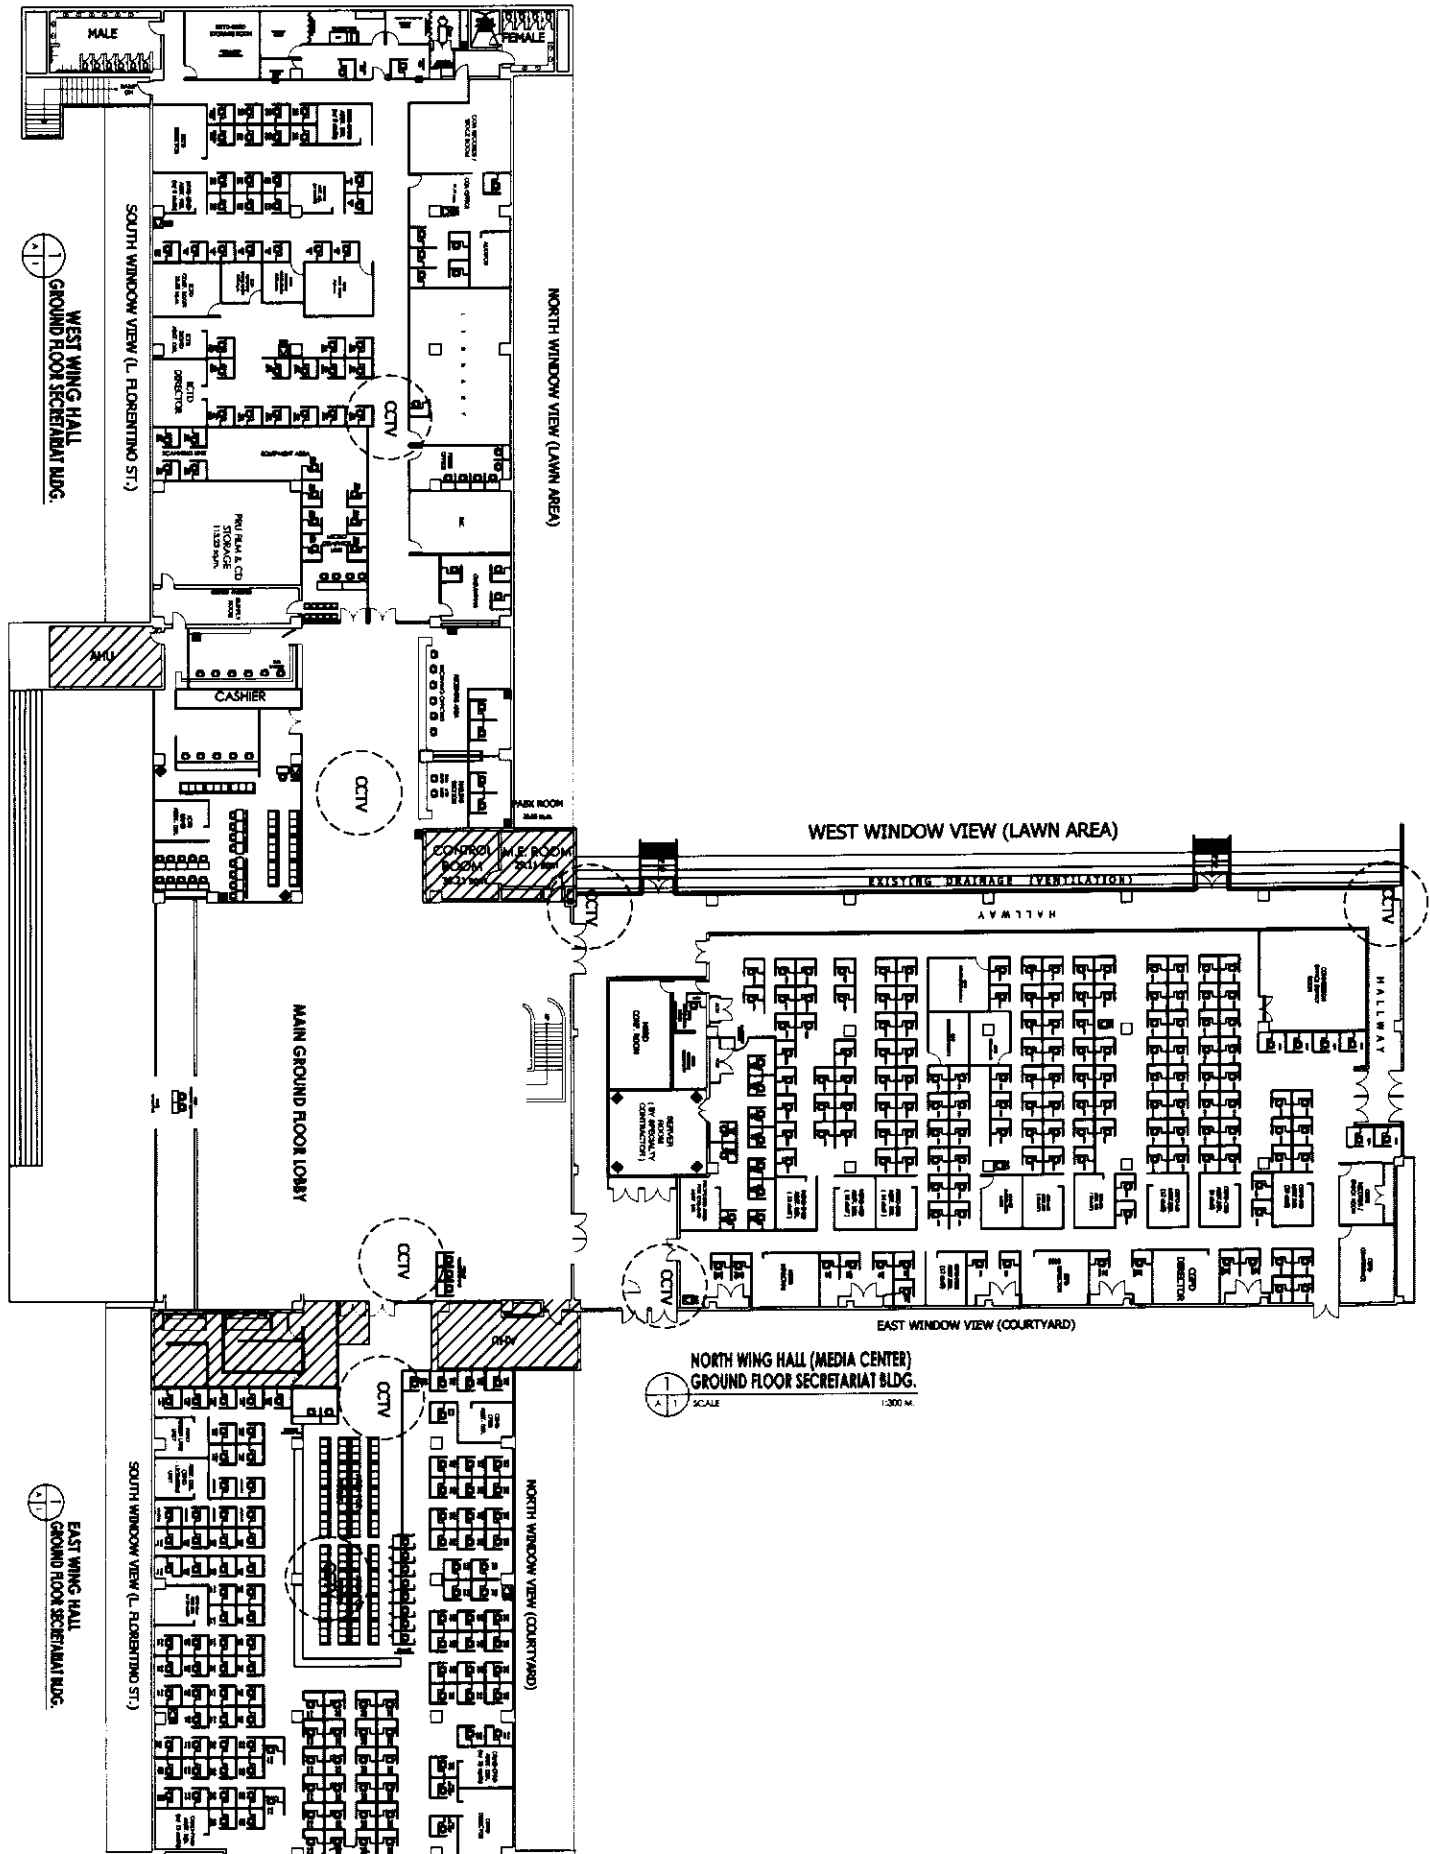


WEST WING HALL
GROUND FLOOR SECRETARIAT BLDG.

EAST WING HALL
GROUND FLOOR SECRETARIAT BLDG.

NORTH WING HALL (MEDIA CENTER)
GROUND FLOOR SECRETARIAT BLDG.
SCALE 1:300 M.

SOUTH WINDOW VIEW (L. FLORENTINO ST.)

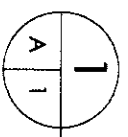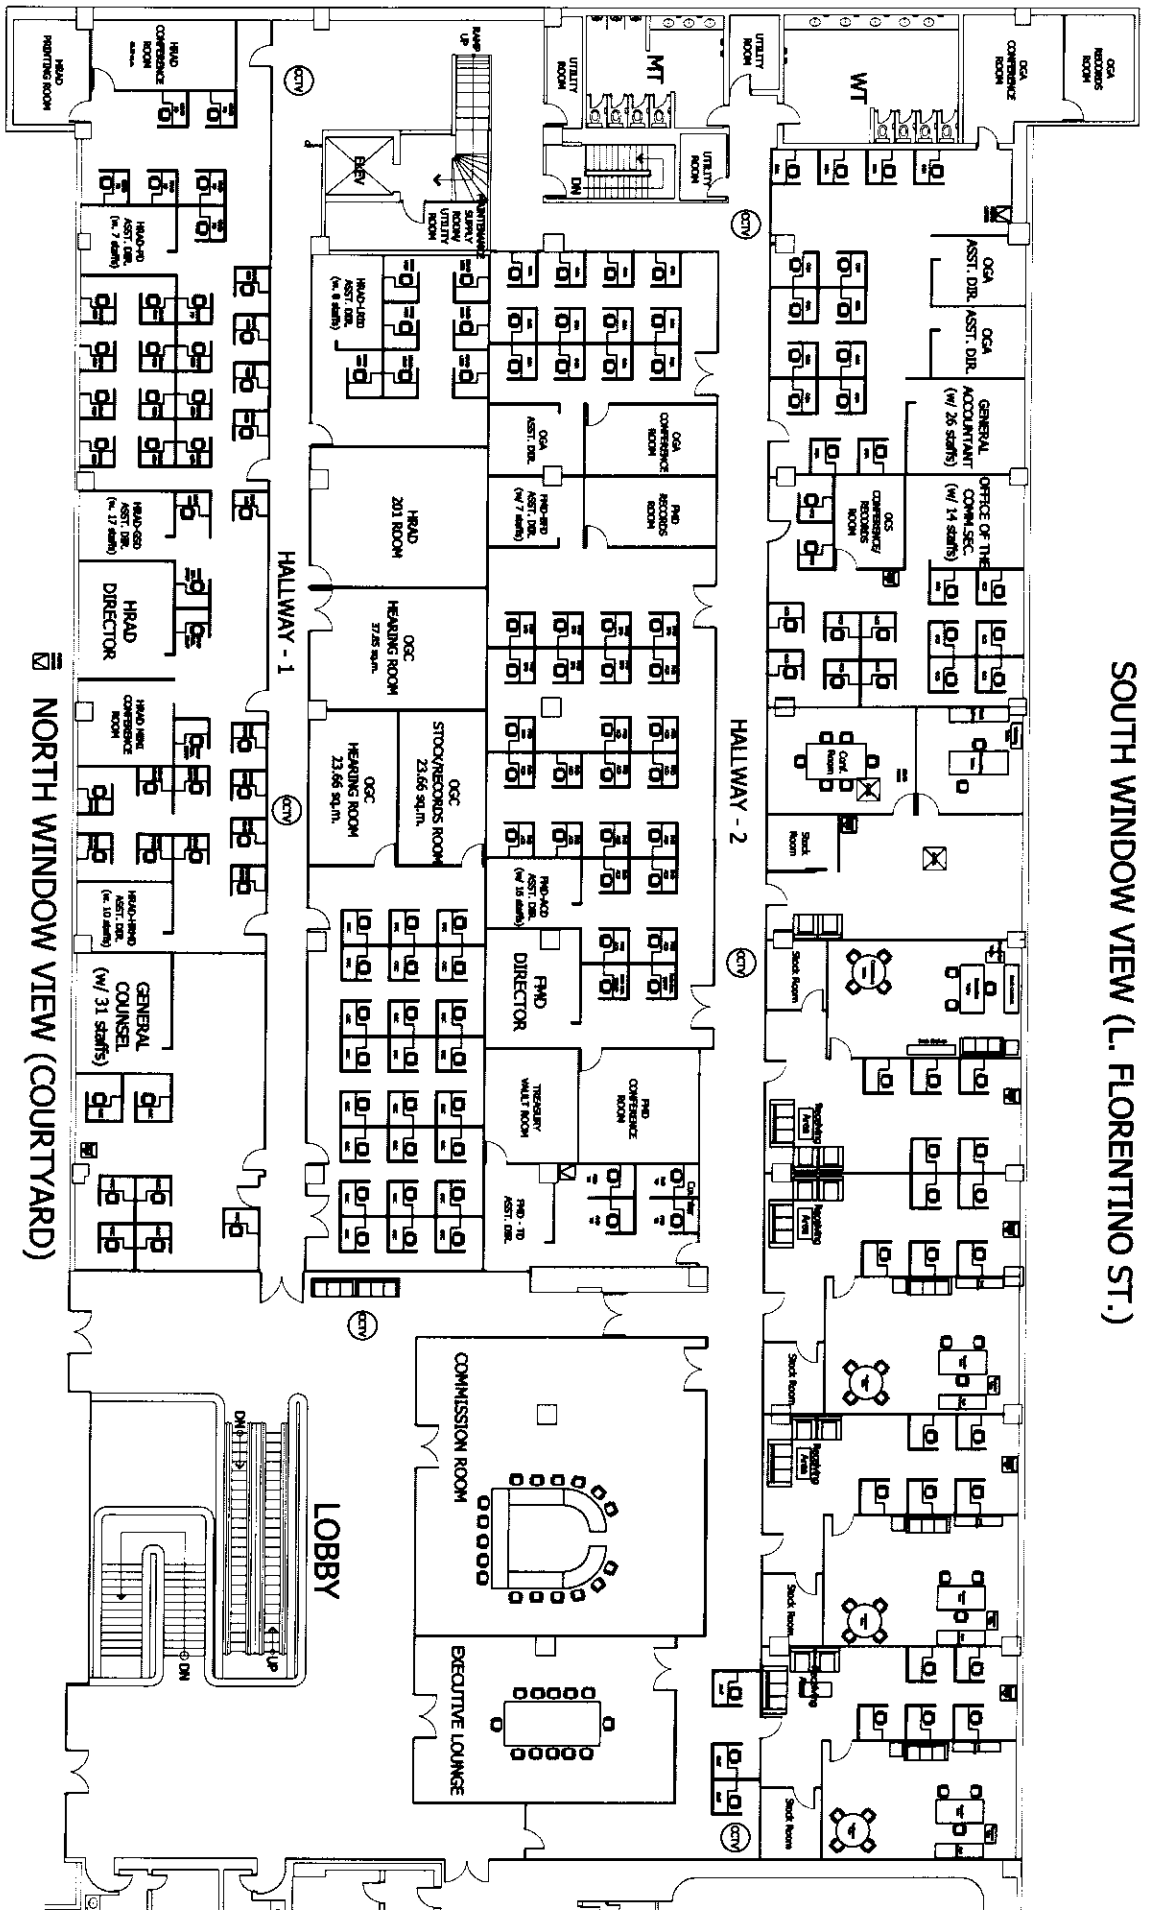

1 THIRD FLOOR SECRETARIAT BUILDING

NOT TO SCALE

PROPOSED LOCATION OF CCTV CAMERAS